



- NOTE
1. Do not scale from this drawing.
 2. All dimensions to be checked on site by the contractor and such dimensions to be his responsibility.
 3. Report all drawing errors, omissions and discrepancies to the architect.
 4. This document may be issued in an uncontrolled CAD format to enable others to use it as background information to make alterations and/or additions. In that instance the file will be accompanied by a PDF version. It is for those making such alterations and additions to ensure that they make use of current background information. Tone accepts no liability for any such alterations or additions to the background information or arising out of changes to background information which occur prior to alterations of additions being made.

 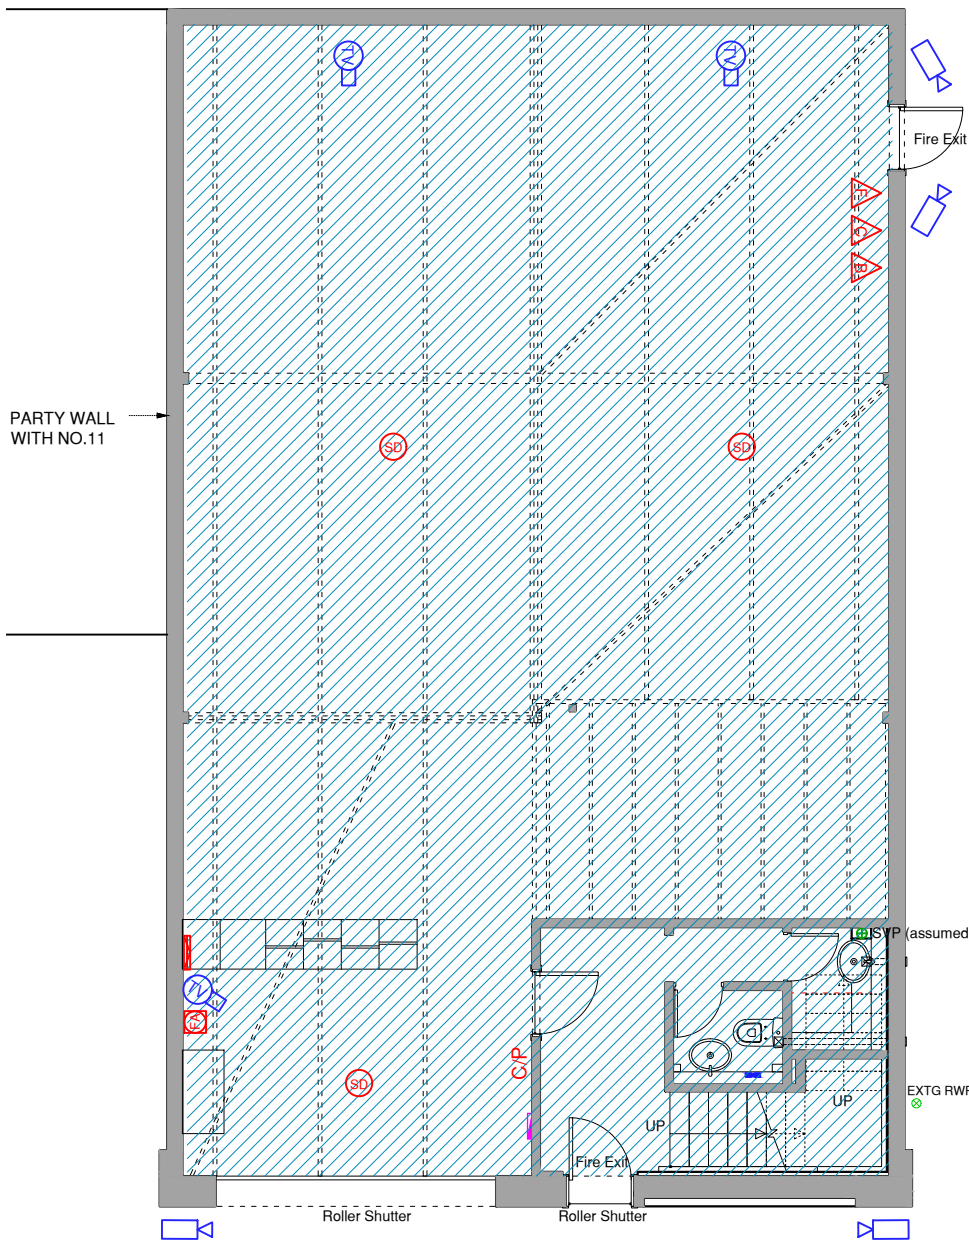


PROPOSED GROUND FLOOR PLAN
TOTAL AREA 142m²

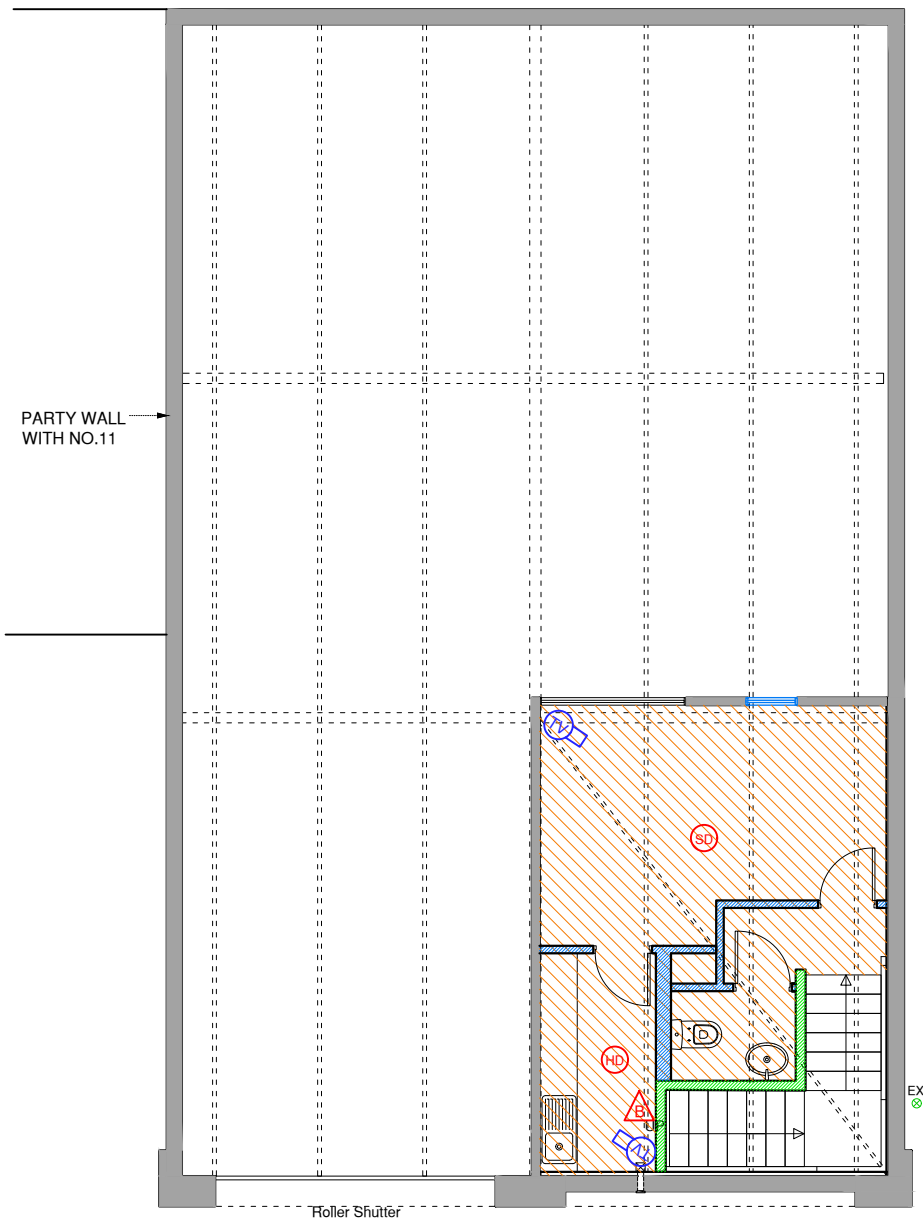

PROPOSED MEZZANINE FLOOR PLAN
TOTAL AREA 23 m²

- Licenced area 137m²
- Mezzanine floor 20m²
- Fire Alarm Control Panel
- Fire Alarm Call Point
- Smoke Detector / sounder
- Heat Detector
- Internal CCTV Camera
- External CCTV Camera
- CCTV Monitor
- Fire Extinguisher - Foam
- Fire Extinguisher - Chemical
- Fire Blanket



Only scale from drawings for planning purposes. All discrepancies to be reported to the designer immediately. All dimensions to be verified by the contractor on-site prior to any works commencing. This drawing is copyright and remains the property of Mox Design Studio Ltd.



MOOX DESIGN STUDIO LTD.
284 CHASE ROAD, BLOCK A
2ND FLOOR, N14 6HF
SOUTHGATE, LONDON
tel: 0800 488 0849
www.mooxdesignstudio.co.uk
email: info@mooxdesignstudio.co.uk

Project:
Cumberland Park
Scrubs Ln, London NW10 6RE

Drawing Title:
LICENCING

Drawing no: 21825.BR3 Scale: 1:100 Date: 31.08.2021
Revision: 1 Status: P1 FIRST ISSUE