



Location Plan scale 1:1250

- Red outlined areas are part of the premises
- Blue outlined areas are communal

fire extinguisher
fire blanket
exit
Fire equipment

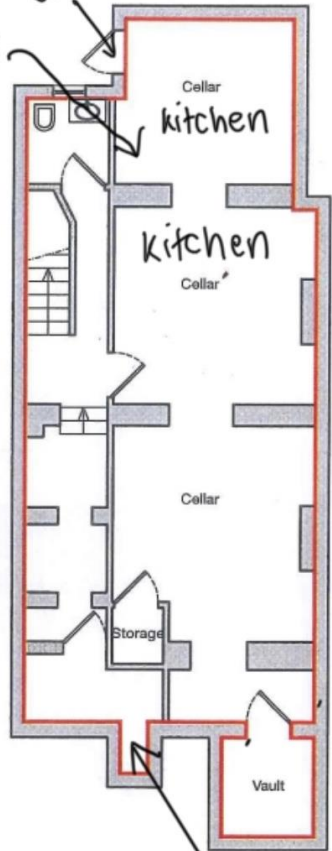

Basement Plan

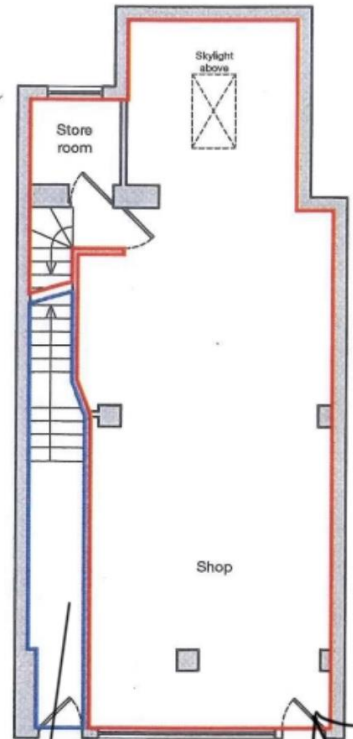

Ground Floor Plan

Emergency exit
fire extinguisher
fire blanket
Fire equipment
Entrance/exit
North End Road



1:100 when scale bar measures 10 cm when printed

98 North end Road
London W14 9EX

Lease plans		
Scale: 1:100 @ A3	Date: 21/05/2019	
Project code: LNSGS	Drawing no. 100	Revision:

